




JAMES K. QUINA, JR., P.E.
CONSULTING ENGINEER
P. O. BOX 600183
ST. JOHNS, FLORIDA 32260
(904) 460-5063

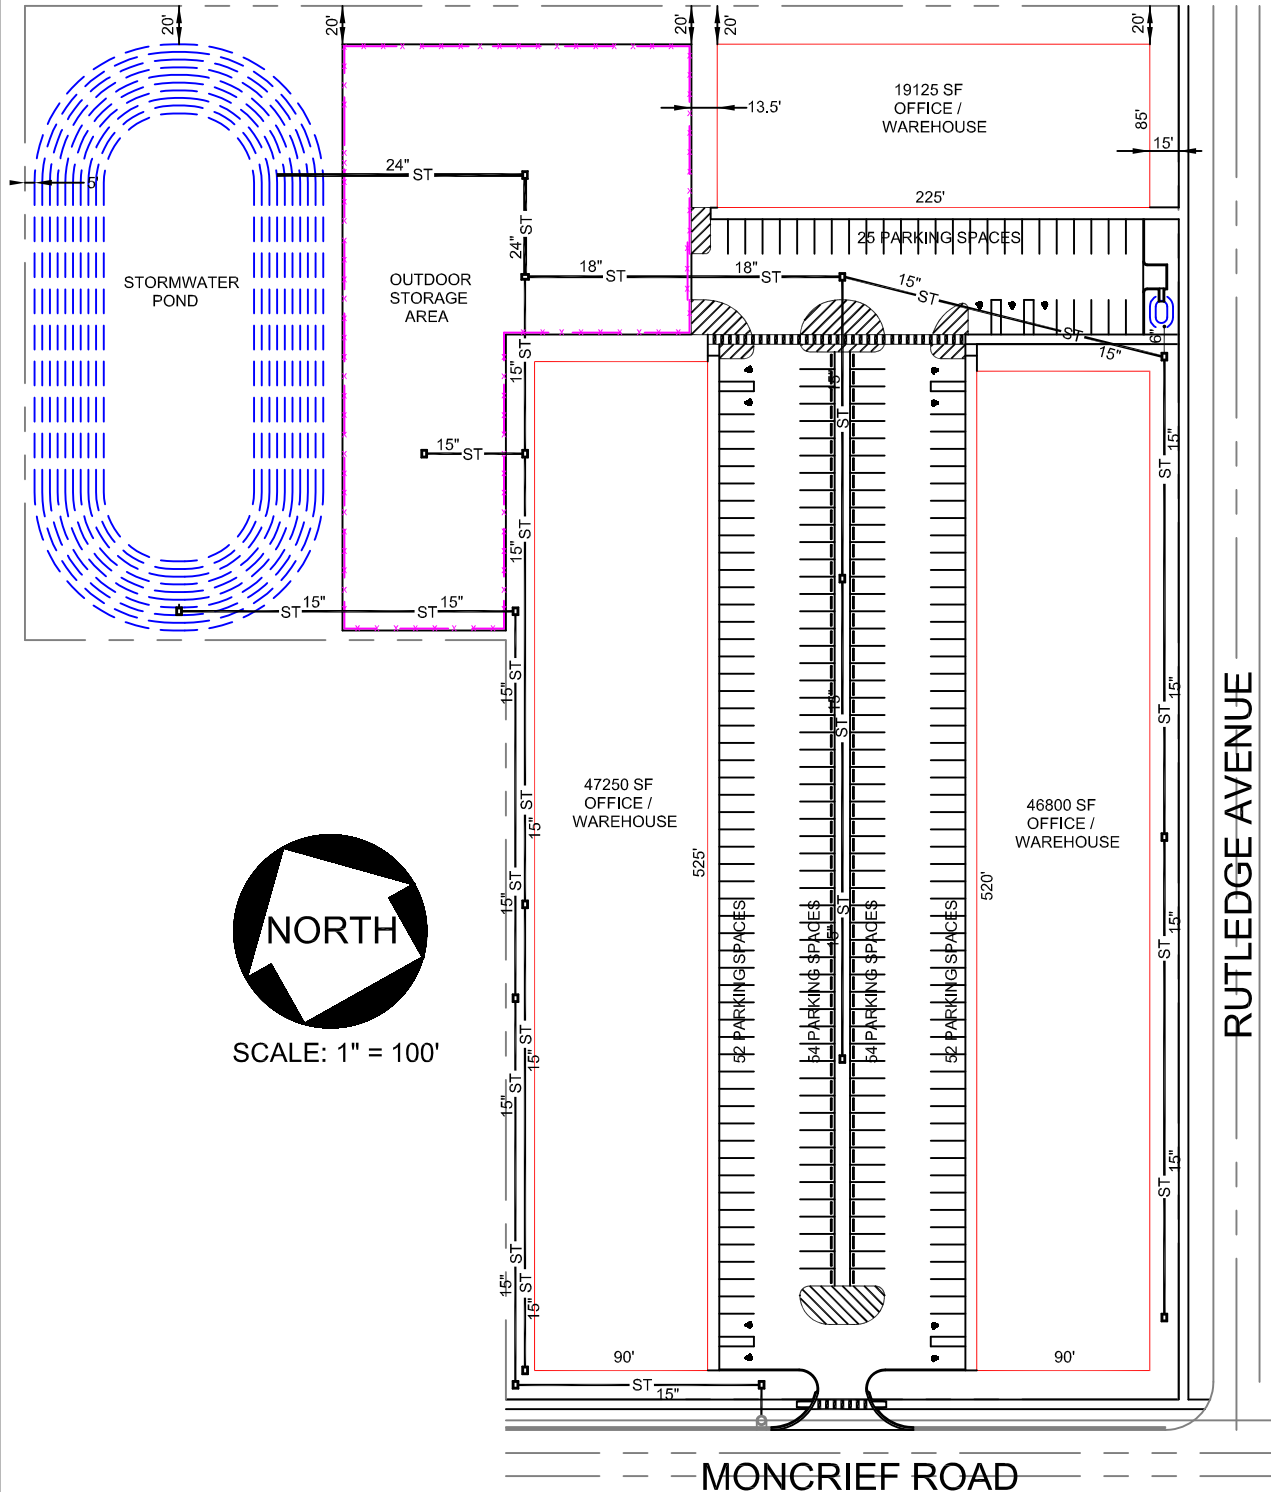

**A.J. WELLS ROOFING
& CONSTRUCTION, INC.**
941 BLANCHE STREET
JACKSONVILLE, FL. 32204
(904) 446-0616

SITE PLAN
5713 MONCRIEF ROAD
JACKSONVILLE, FLORIDA

JAMES K. QUINA, P.E.
CIVIL ENGINEER

FL. LICENSE No.: 37776

DRAWN BY: JKQ

DATE: 5-27-25

SHEET No.

Exhibit 4
Page 1 of 1

C1

1 OF 1